


EXTERIOR. ELEVATIONS

SCALE: 1/4" = 1'-0"


5

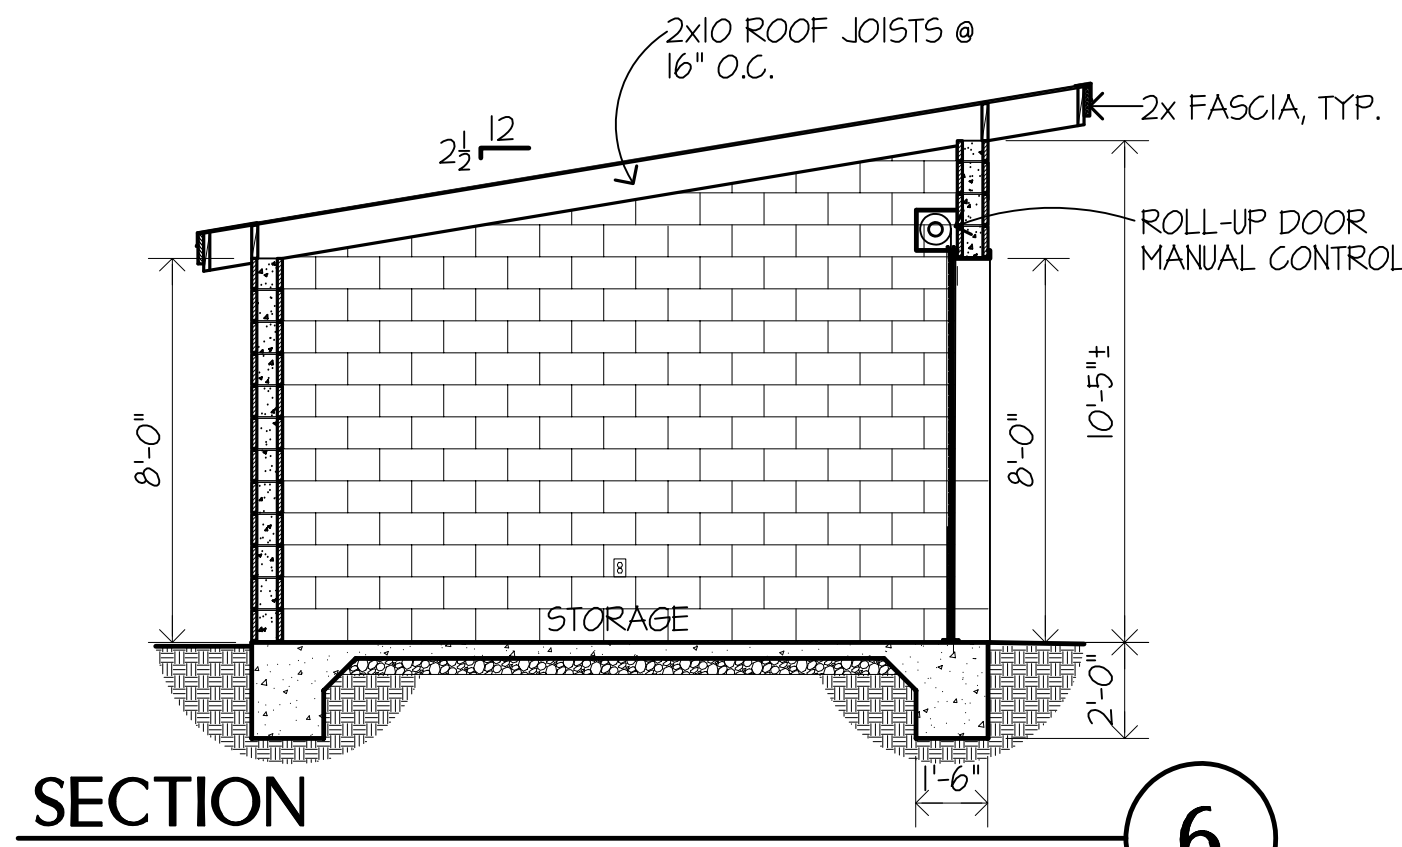

SECTION

SCALE: 1/4" = 1'-0"


6

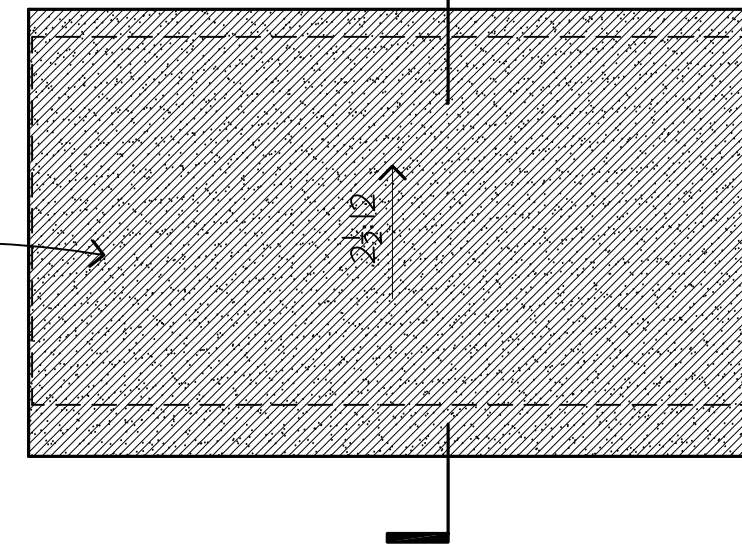

ROOF PLAN

SCALE: 1/8" = 1'-0"


4

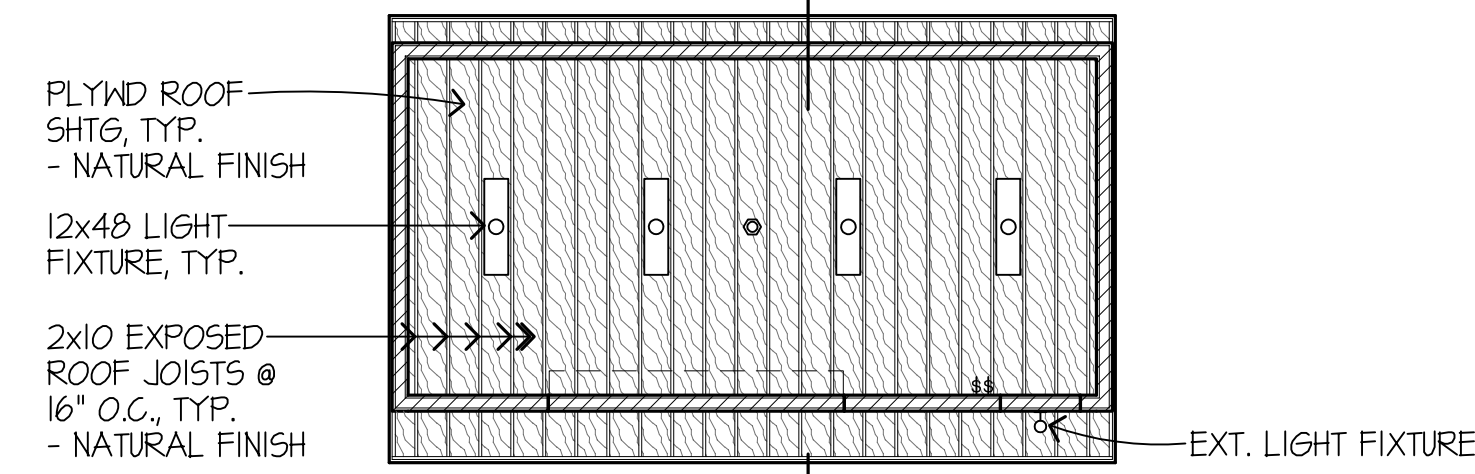

REFL. CEILING PLAN

SCALE: 1/8" = 1'-0"

3

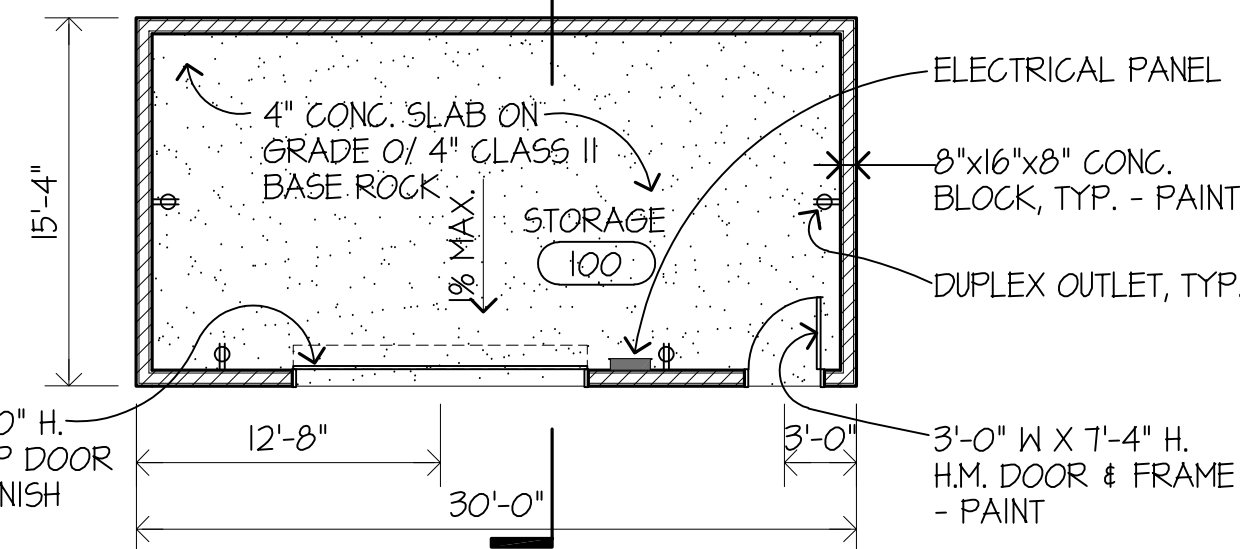


FLOOR PLAN / POWER PLAN

SCALE: 1/8" = 1'-0"

2

GENERAL NOTES

1. SITE PLAN INFORMATION TAKEN FROM DWGS BY WLC ARCHITECTS, DATED 5/23/17

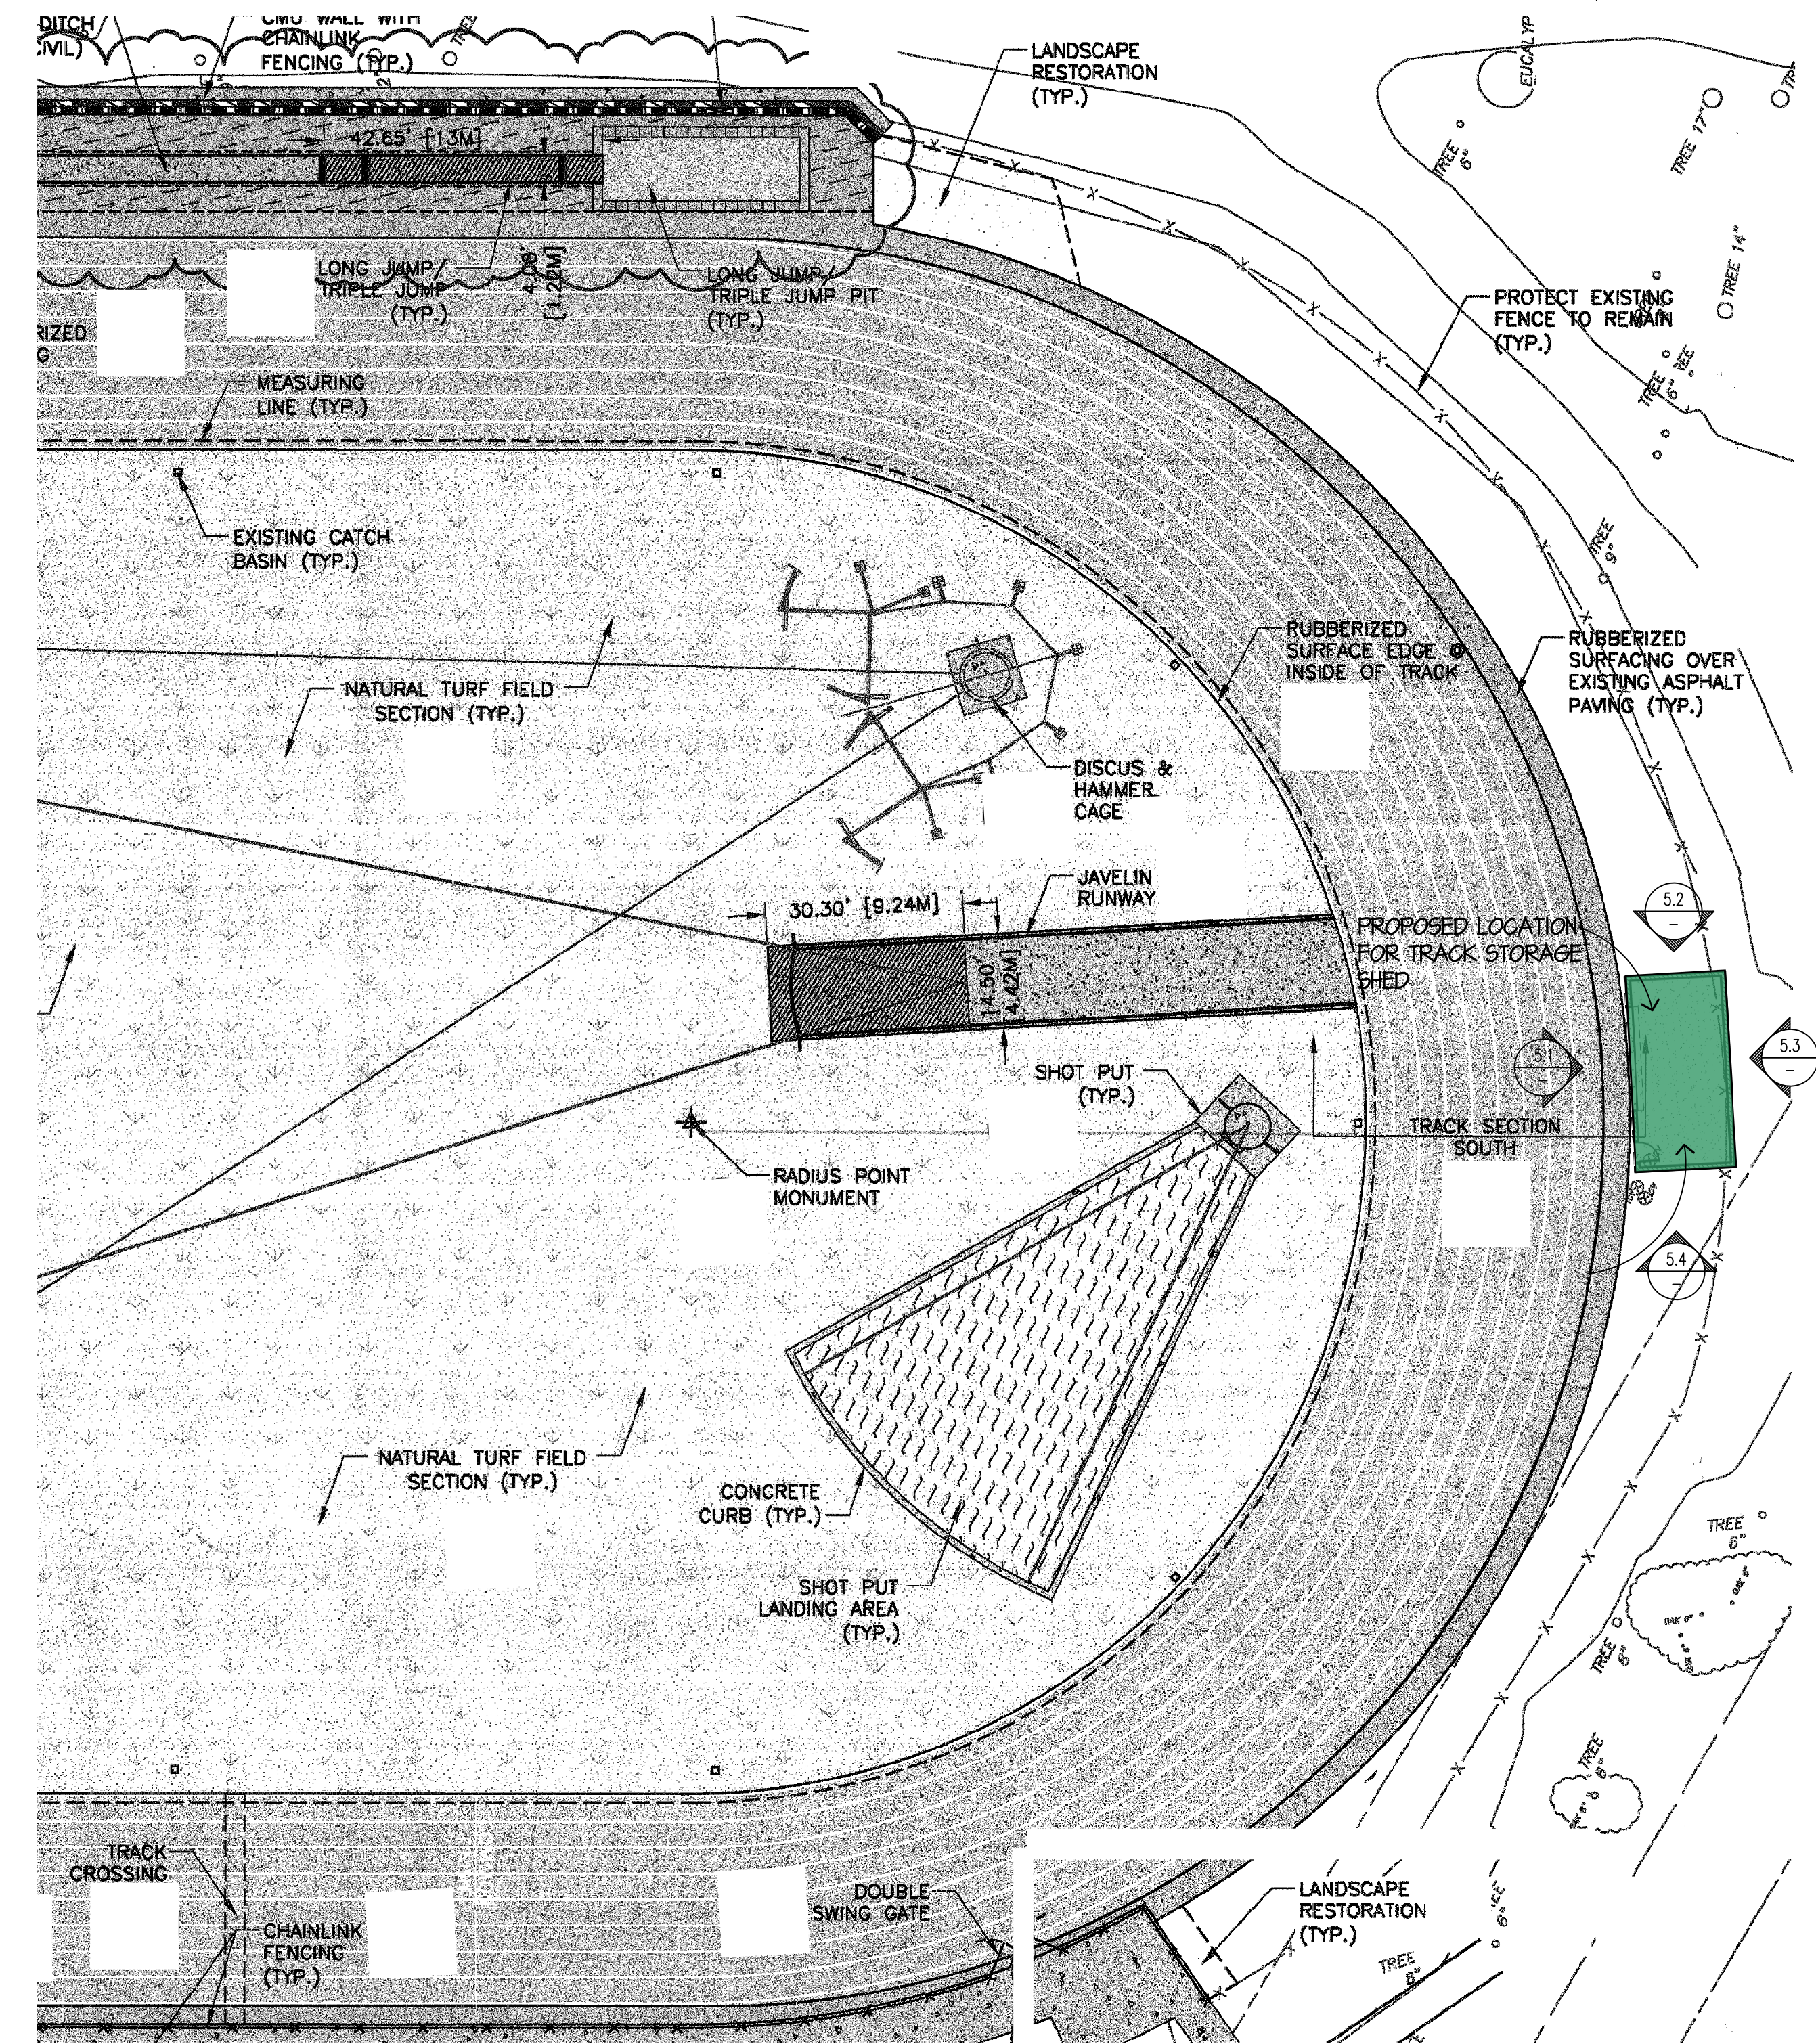

PARTIAL SITE PLAN

SCALE: 1" = 20'-0"

1



Total Estimated Cost: \$40,351.24
 Total Estimate Material Cost: \$17,074.81
 Total Estimated Labor Cost: \$18,013.23

Total Schedule Duration: 231 Days
 Total Construction Schedule Duration: 48 Days

SENIOR PROJECT
 JONATHAN CHAGNON
 DECEMBER 2, 2021

TRACK & FIELD HURDLE SHED